


位置図

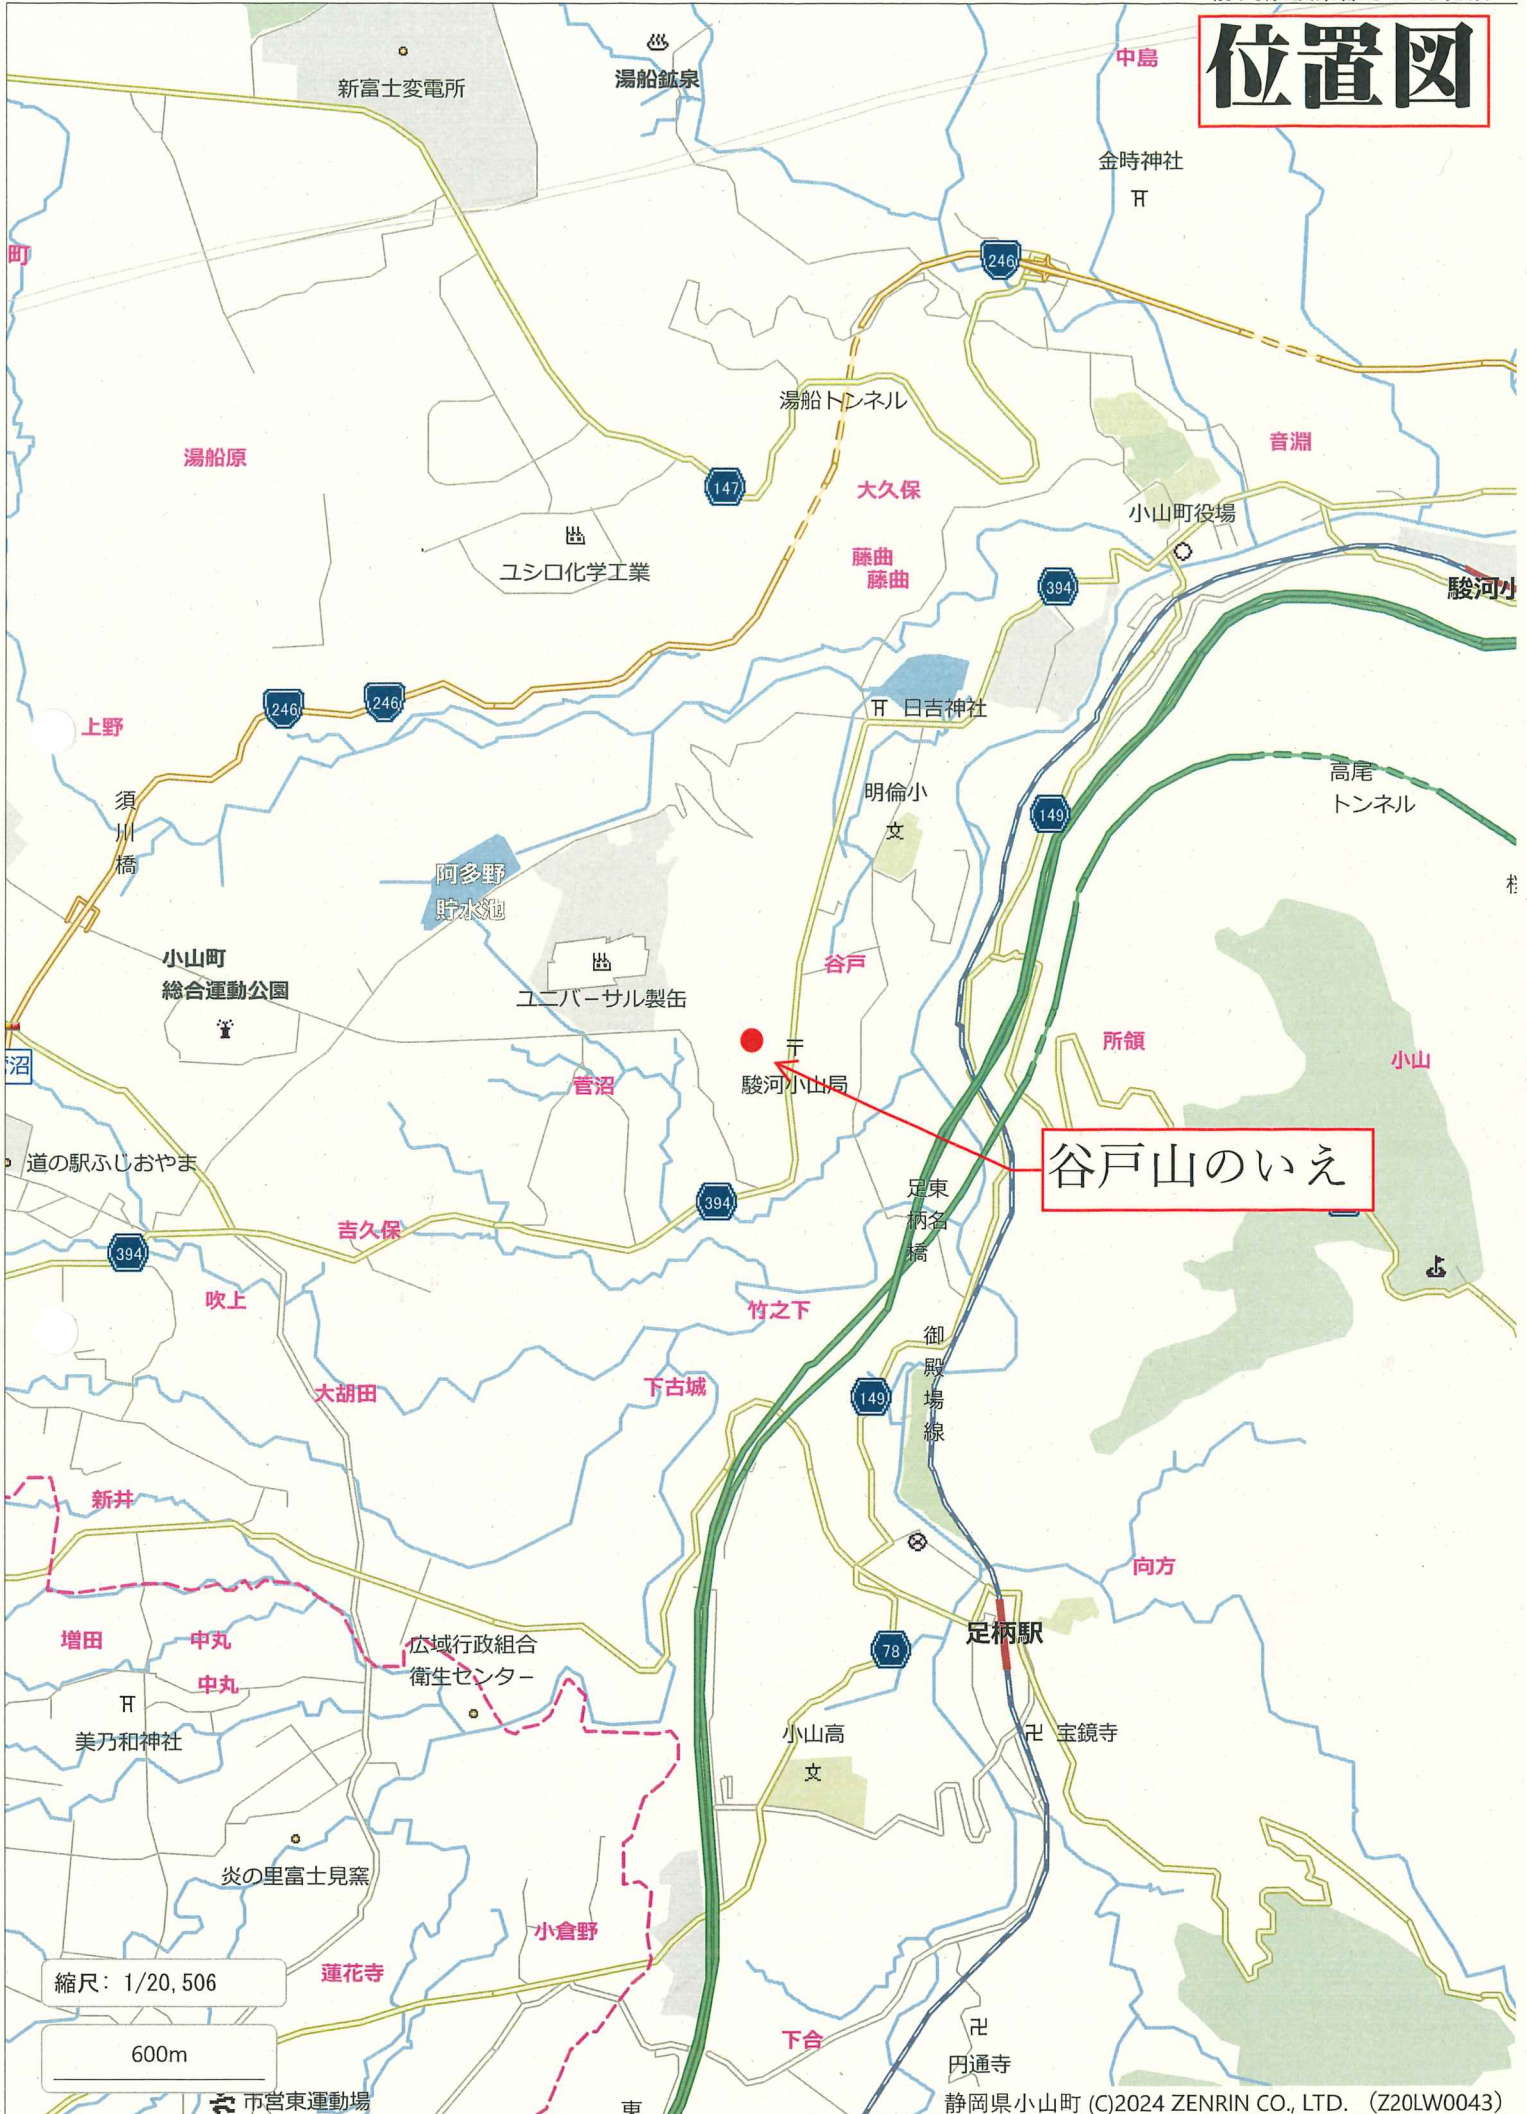

谷戸山のいえ


 
縮尺: 1/20,506



600m

配置図



改修前 (母屋古民家)

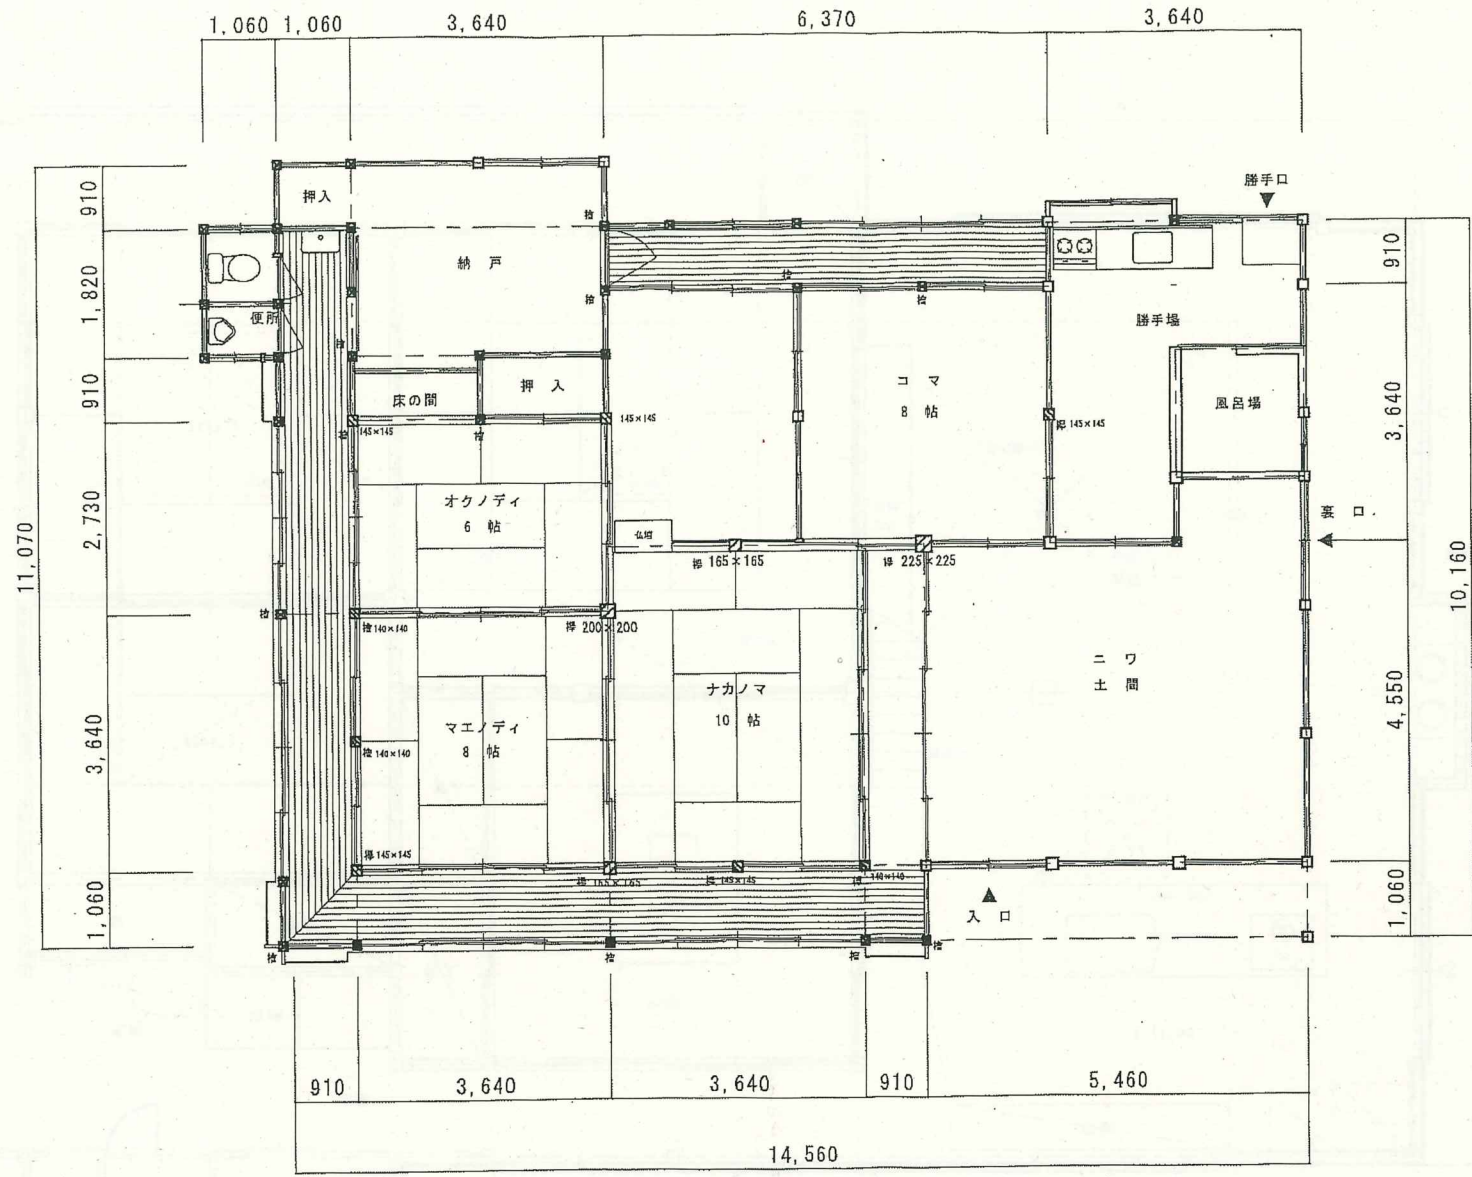

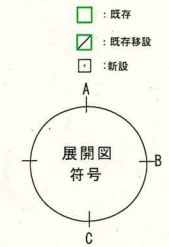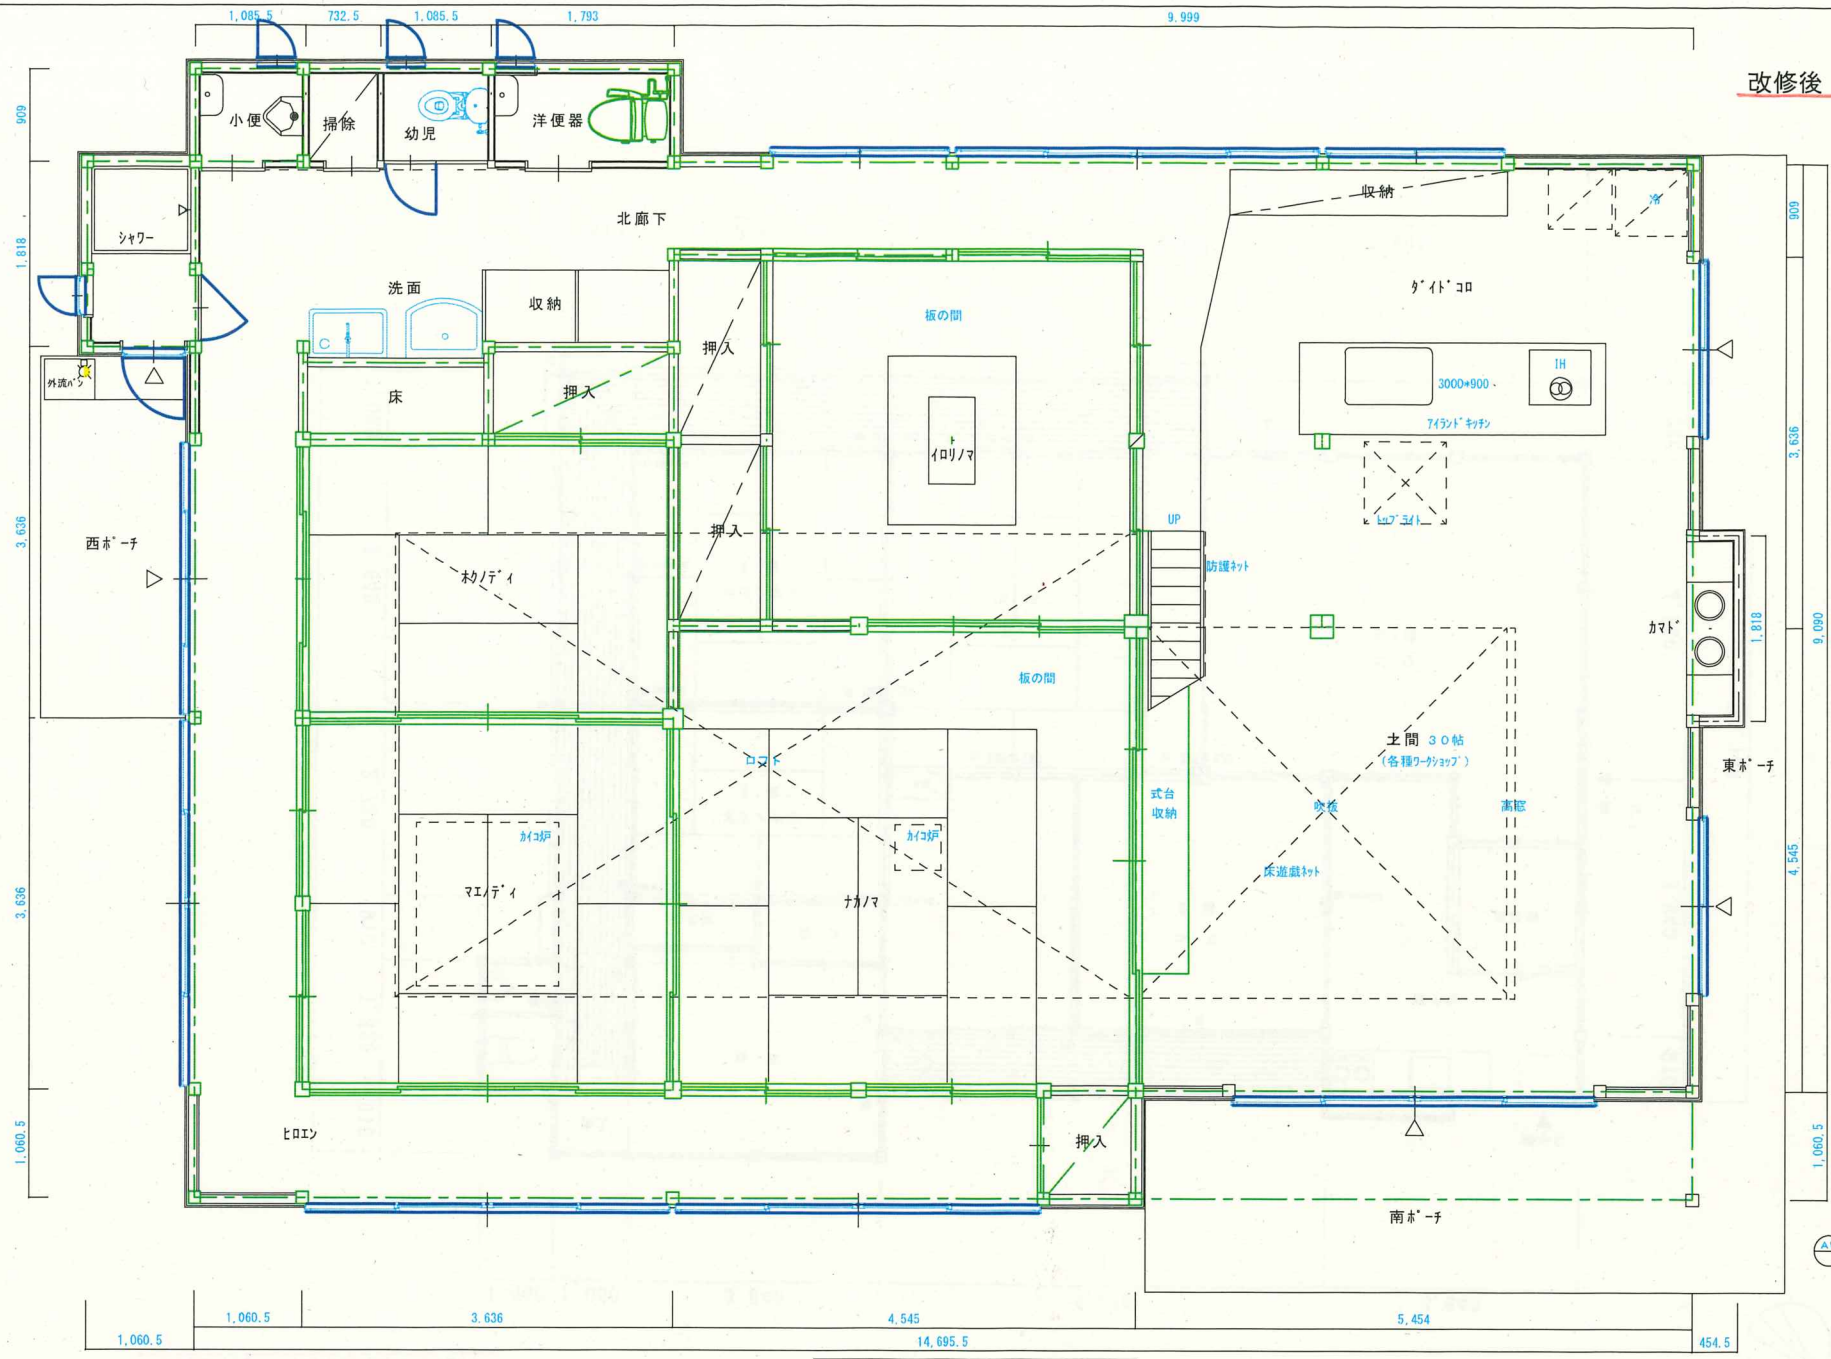


- AW AD WD FD PD 建具符号
- 0-24時間
 - 通柱、金物、スジカいは伏図参照
 - W: 大壁
 - * 既存材
 - ☒ 塩ビ給気口φ75 (15.10m²)
 - ⊗ 換気扇

1階平面図 S = 1/50

建築面積: 156.19m² (47.24坪)
 1階床面積: 150.41m² (47.50坪)
 2階床面積: 39.66m² (12.00坪)

離れ 改修前

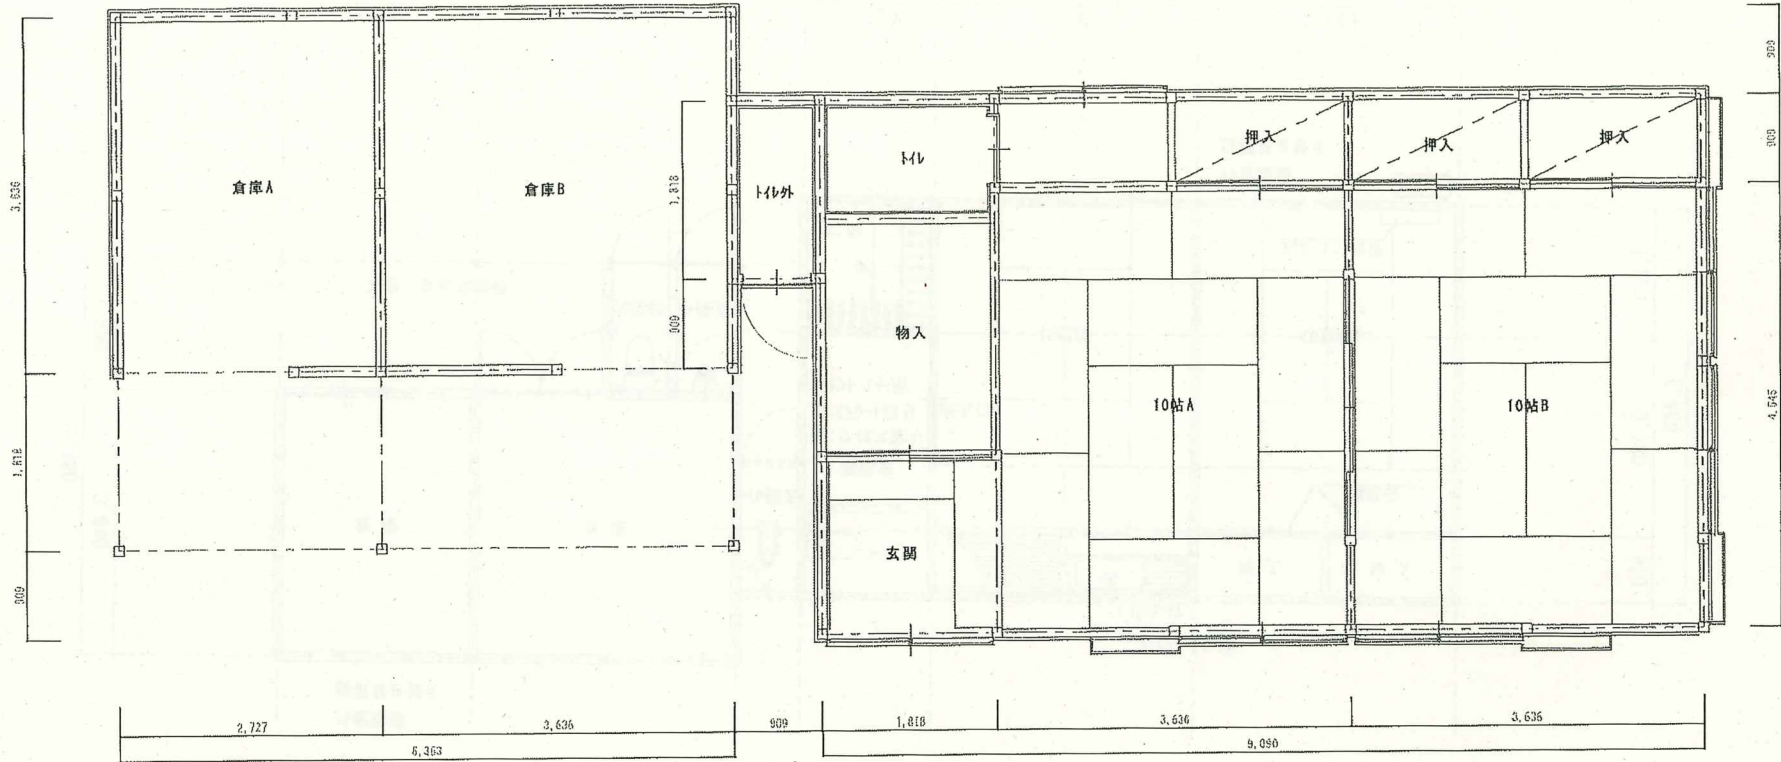



脇屋 平面図 S=1/50

離れ 改修後

離れ (倉庫)

離れ (住居)

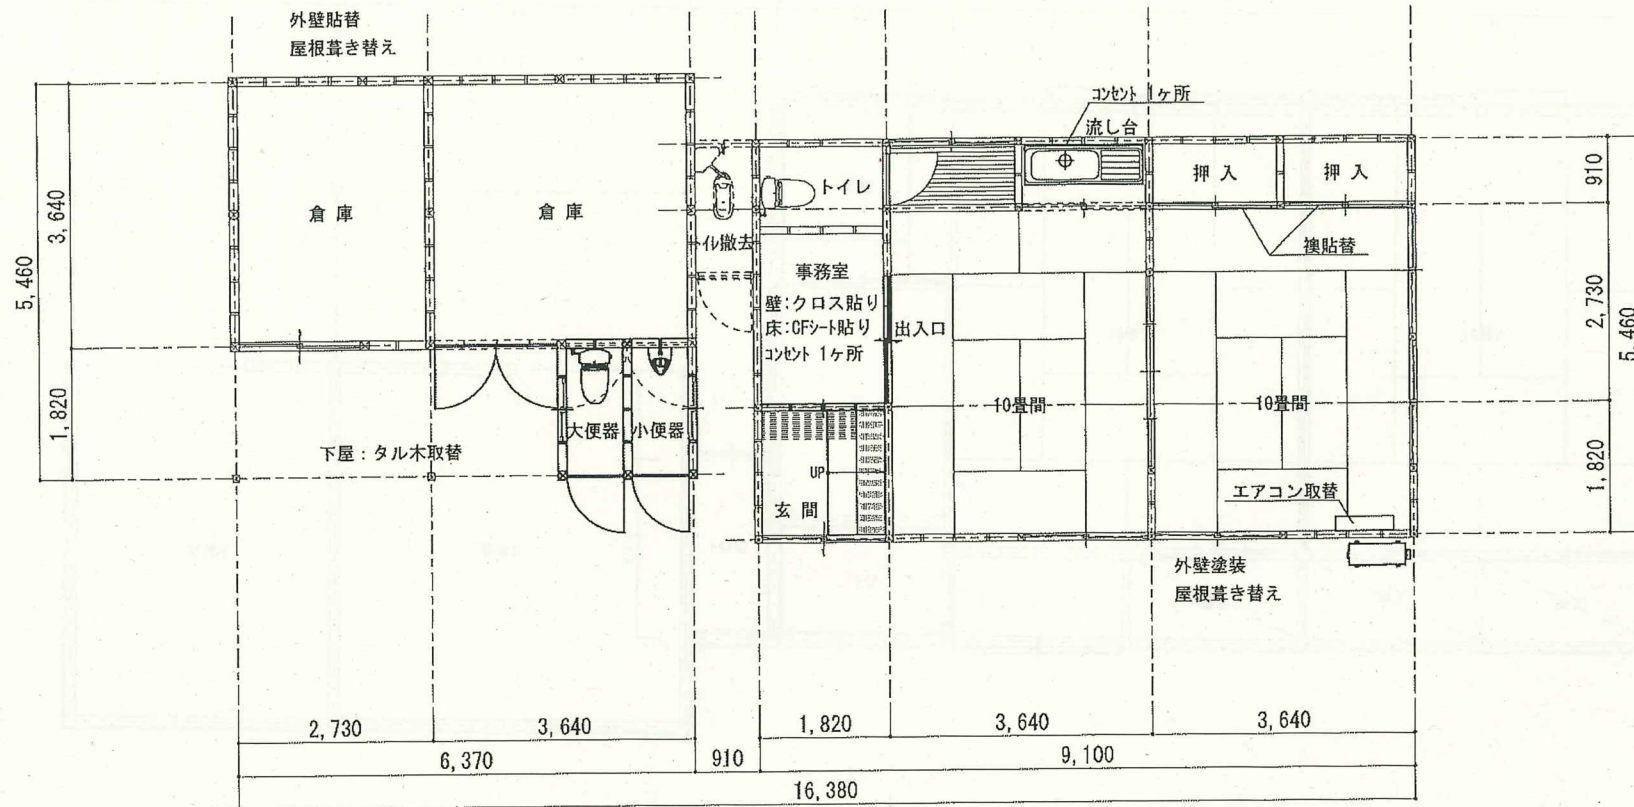

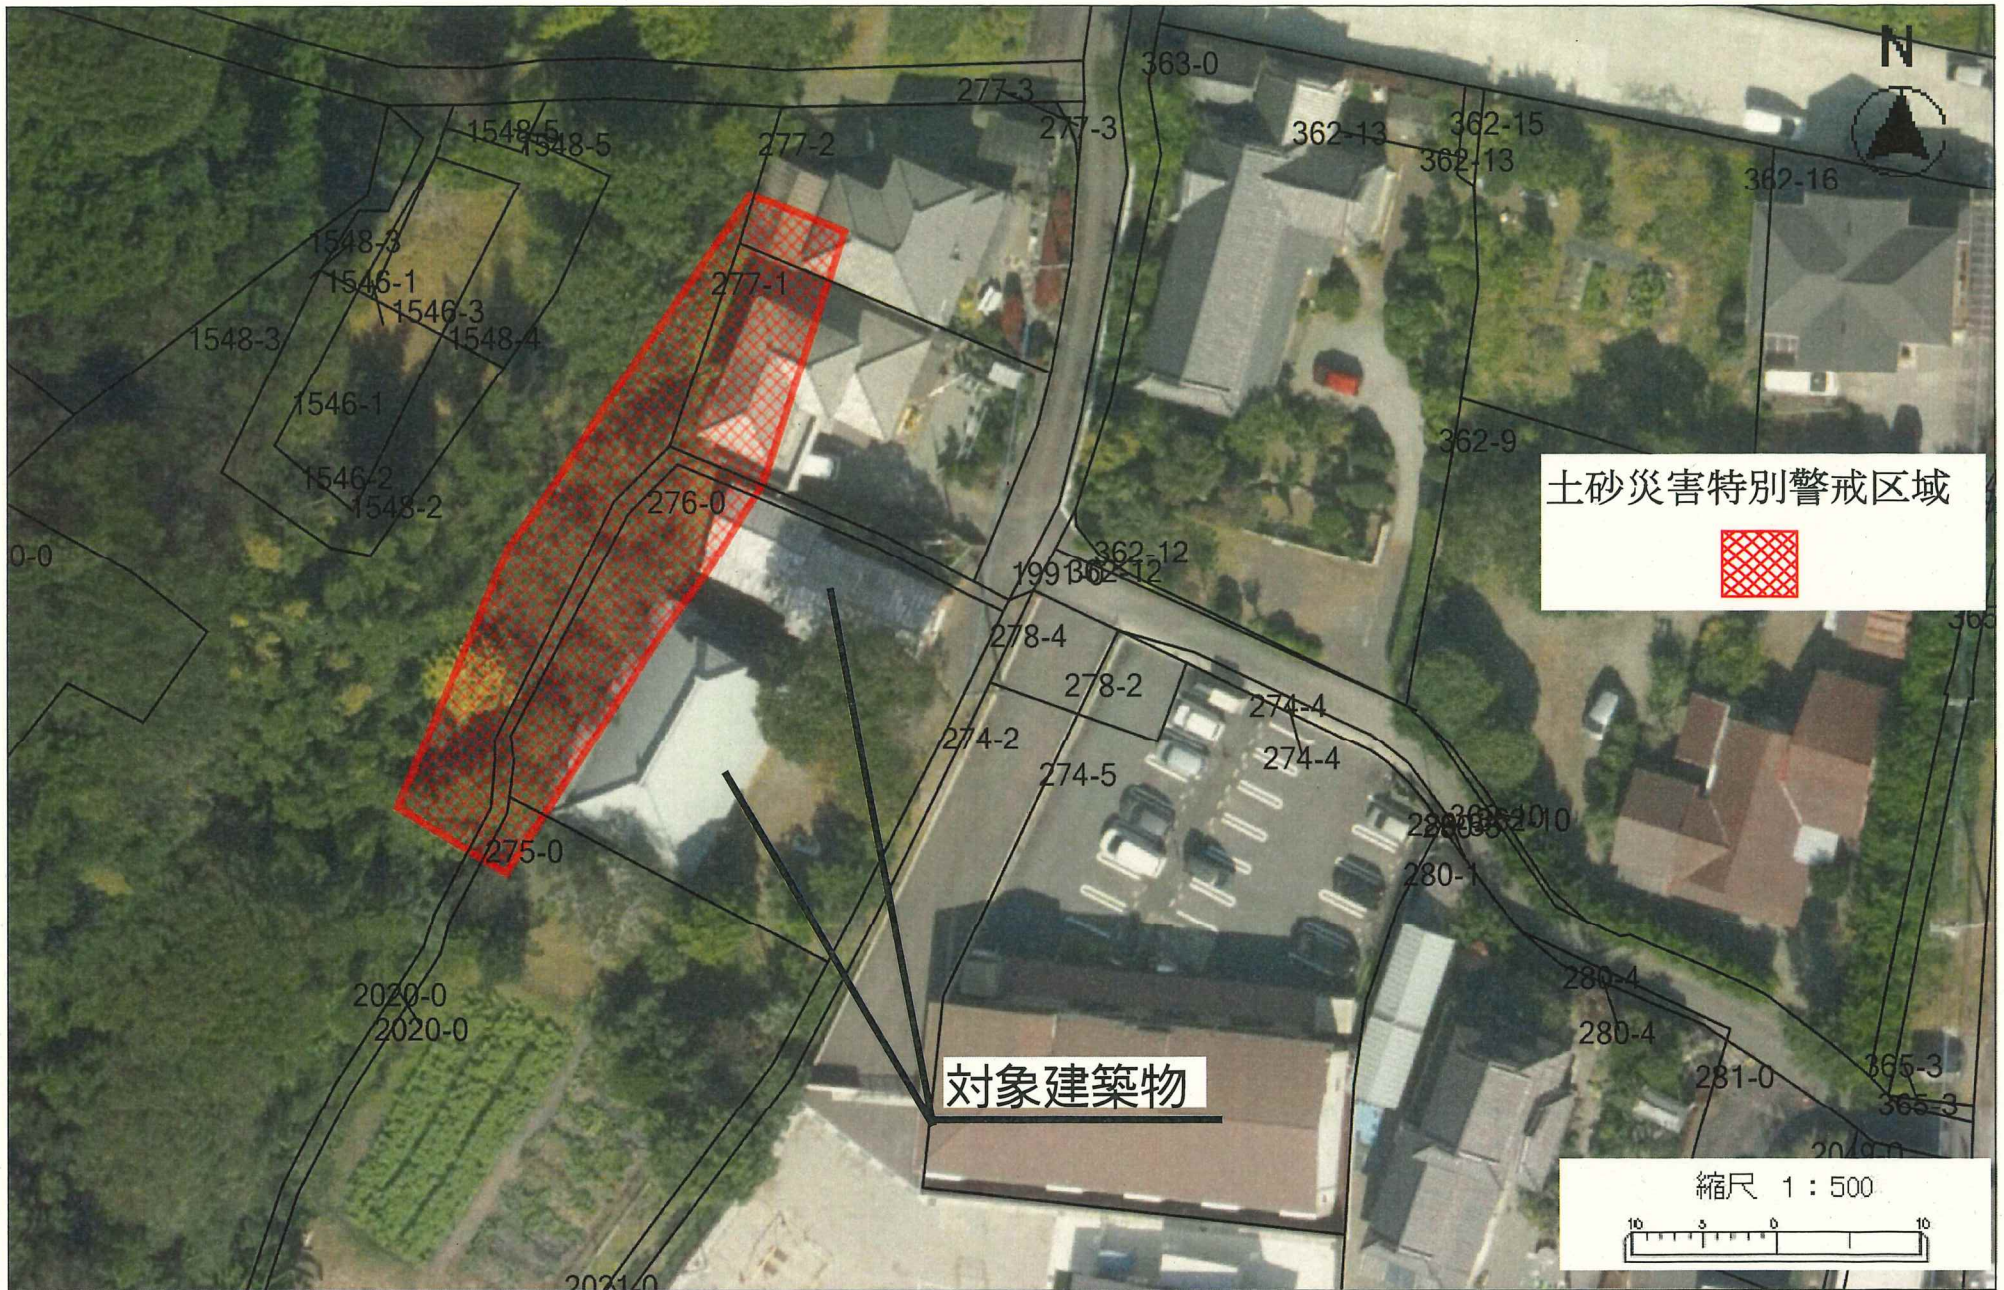



施行予定範囲

縮尺 1 : 500

